
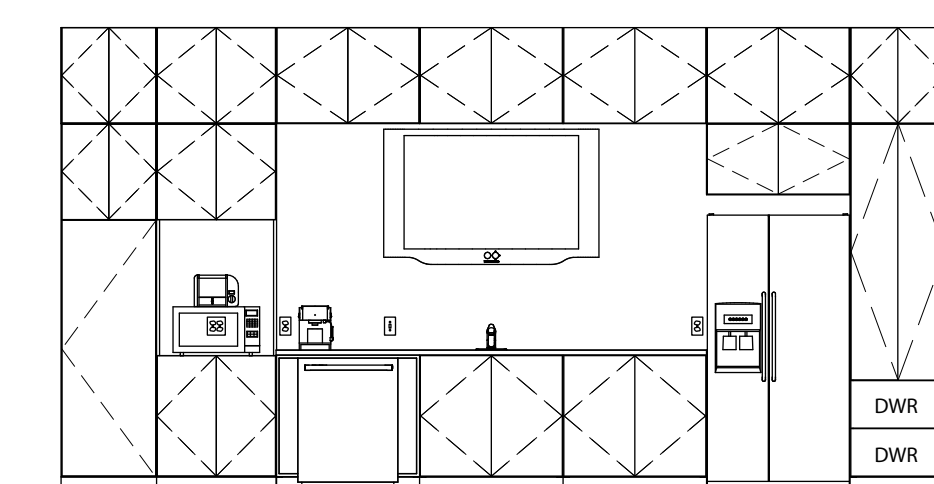


REVISIONS BY:

5150 WILSHIRE BLVD.
LOS ANGELES, CA 90036
FOURTH LEVEL FLOOR PLAN

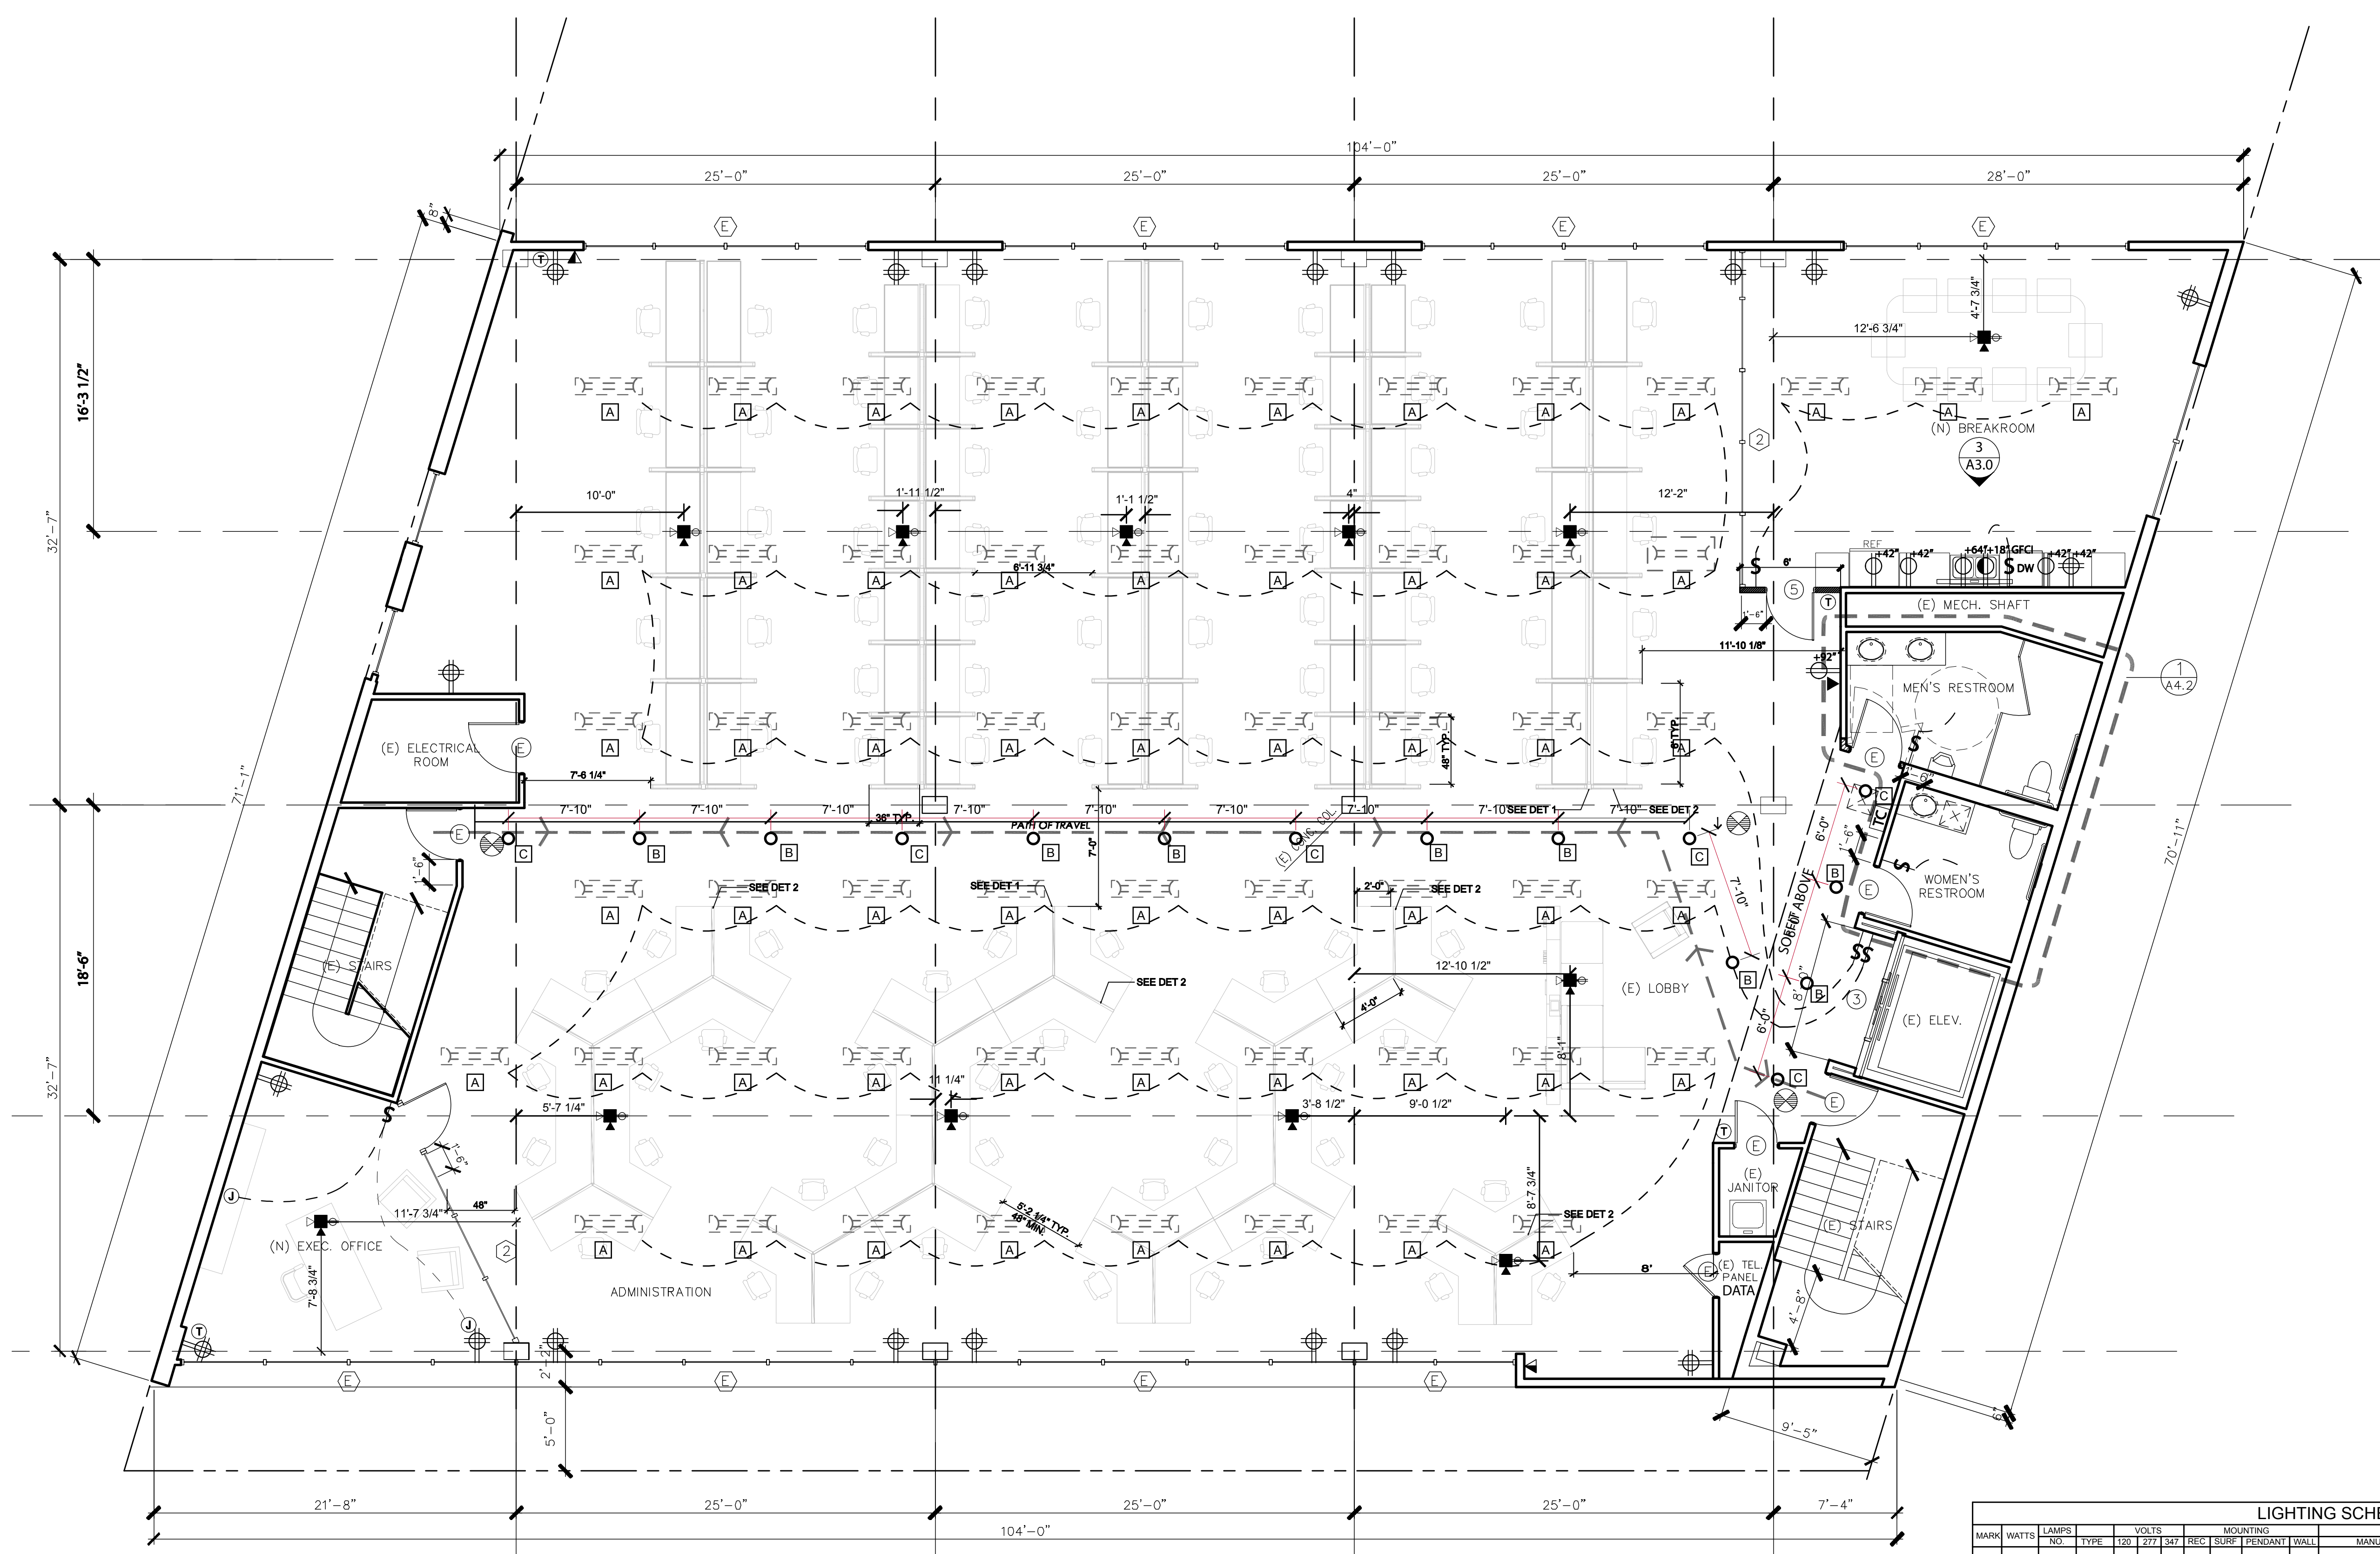

INTERIOR ELEVATION
DETAIL 3 1/4"=1'-0"

ELECTRICAL LEGEND:

- SWITCH
- DUPLEX OUTLET
- SPLIT WIRED GROUND FAULT CIRCUIT INTERRUPT DUPLEX OUTLET
- QUADPLEX OUTLET
- DATA JACK
- TELEPHONE/DATA JACK
- RECESSED FLOOR MOUNTED COMBINATION
- TIME CLOCK OUTLET
- CEILING MOUNTED JUNCTION BOX
- THERMOSTAT
- INTERIOR ELEVATIONS

WALL LEGENDS:

- (E) PARTITION
- (N) PARTITION, METAL STUDS @ 16" O.C., SEE DETAIL 1/4.2

FLOOR PLAN LEGEND:

- EXIT SIGNS AND DIRECTIONAL EXIT SIGNS W/ MIN. 6" HI X 3/4" STROKE BLOCK LETTERS ON A CONTRASTING BACKGROUND. EXIT SIGNS SHALL ALSO BE CONNECTED TO AN EMERGENCY ELECTRICAL SYSTEM PROVIDED FROM STORAGE BATTERIES, UNIT EQUIPMENT OR AN ON-SITE GENERATOR SET, AND THE SYSTEM SHALL BE INSTALLED IN ACCORDANCE WITH THE ELECTRICAL CODE.
- (E) DOOR
- (E) WINDOW

LIGHTING SCHEDULE

MARK	WATTS	LAMPS NO.	TYPE	120	277	347	REC	SURF	PENDANT	WALL	MANUF.	CAT. NO.	DESCRIPTION	REMARKS
A	32	2	T8	X						X	LITHONIA www.lithonia.com	AVSM 2 32 MDR ULR 120 GEB		
B	33	1	CFT-TR1	X			X				DMF LIGHTING (800)441-4422 www.dmf-lighting.com	F6FV-132-D600C		
C	34	1	CFT-TR1	X			X				DMF LIGHTING (800)441-4422 www.dmf-lighting.com	F6FV-132-EM-D600C		THE EMERGENCY FIXTURE SHALL BE EQUIPPED W/ AUTOMATIC SOLID-STATE VOLTAGE CHARGER, OVERLOAD & SHORT CIRCUIT PROTECTOR, TEST SWITCH & CHARGE RATE INDICATOR LIGHT, AND EXTRA LONG LIFE SEALED MAINTENANCE FREE LEAD ACID BATTERY

FOURTH LEVEL FLOOR PLAN,
ELECTRICAL & REFLECTED CEILING PLAN

date: OCT 2010
scale: 3/16"=1'-0"
drawn:
job: 2251380
sheet:
A3.0
of sheets