


PORTFOLIO

2019-2024

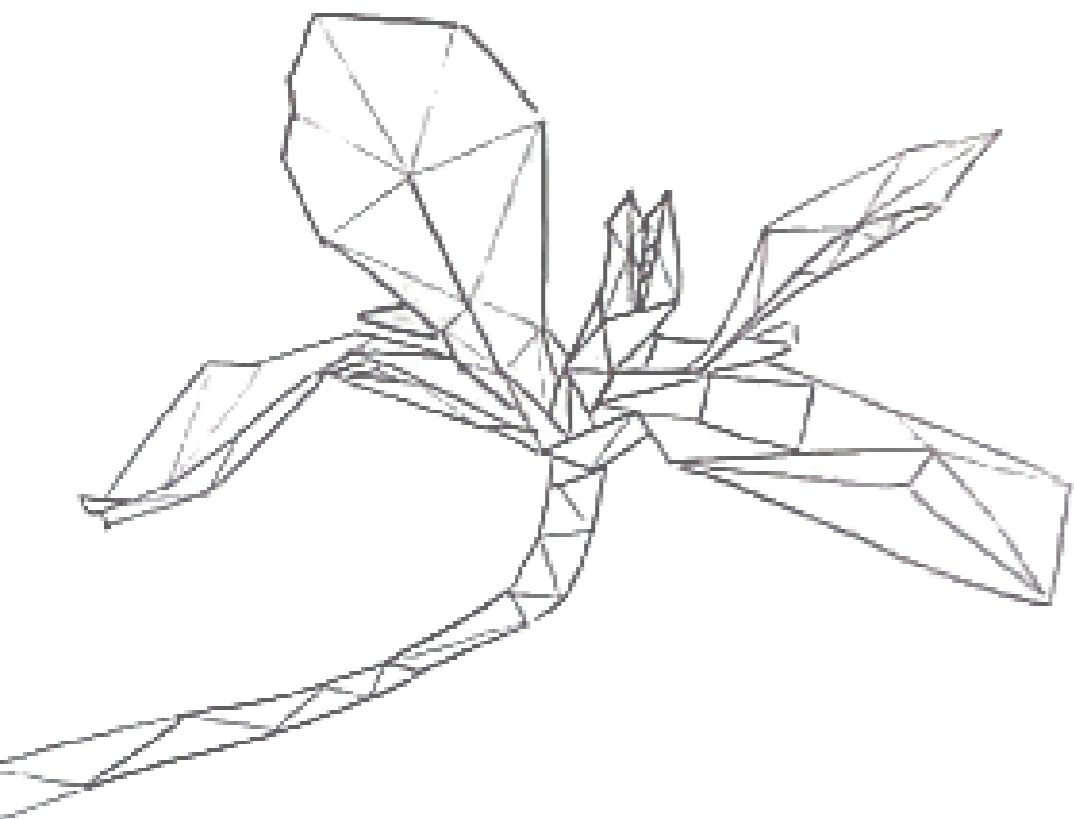

Brian Kimmet

bkimmet@gmail.com

310.880.0284


Westholme

West LA - Residential - 2024


Schematic Design > Design Development >

Construction Documents > Construction Awarding




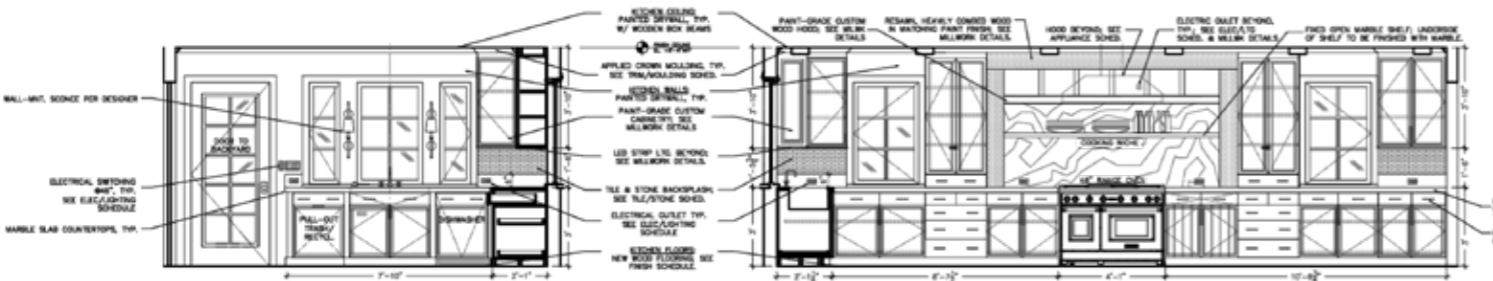


4 KITCHEN EAST INTERIOR ELEVATION SCALE: 1/2"=1'-0"

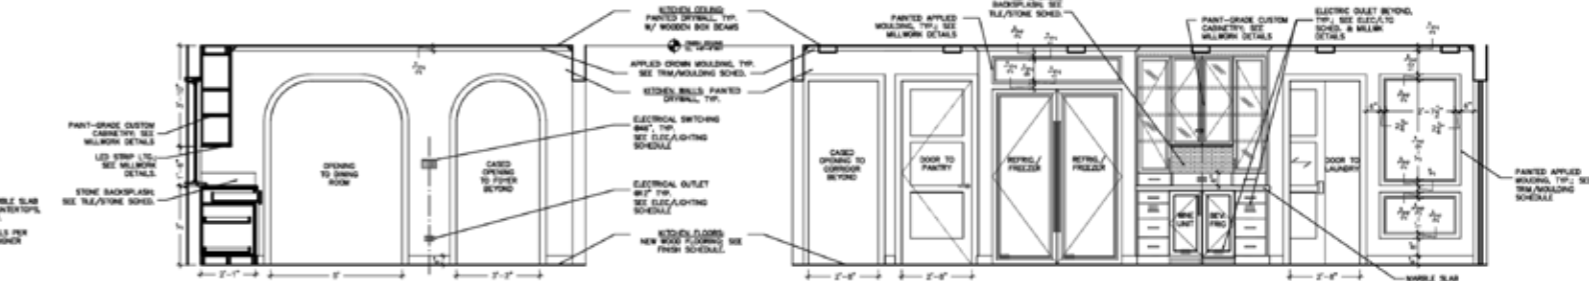

2 KITCHEN WEST INTERIOR ELEVATION SCALE: 1/2"=1'-0"

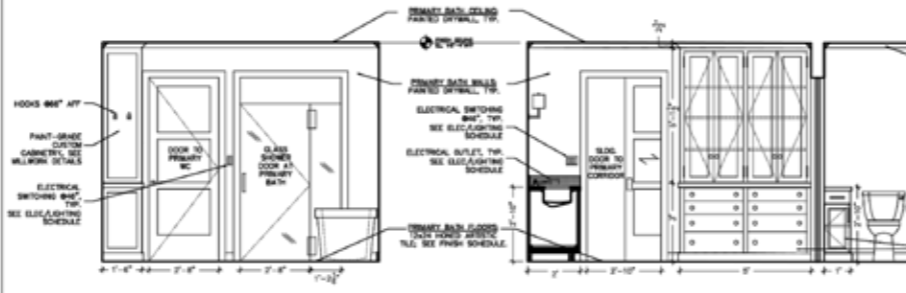


12 PRIMARY BATH WEST INTERIOR ELEVATION SCALE: 1/2"=1'-0"

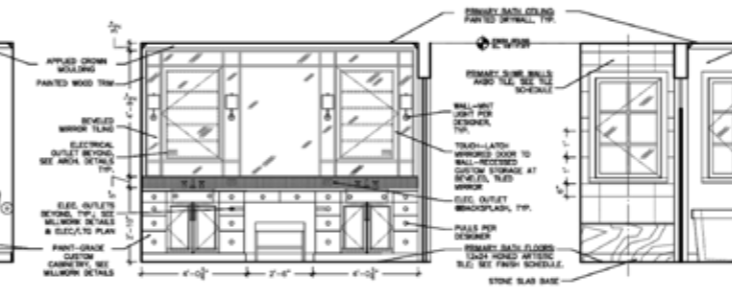

11 PRIMARY BATH SOUTH INTERIOR ELEVATION SCALE: 1/2"=1'-0"




9 PRIMARY BATH NORTH INTERIOR ELEVATION SCALE: 1/2"=1'-0"

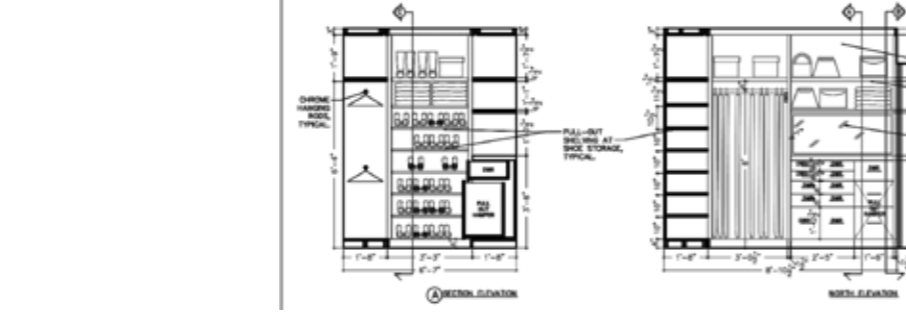


A CLOSET ELEVATION

B CLOSET ELEVATION

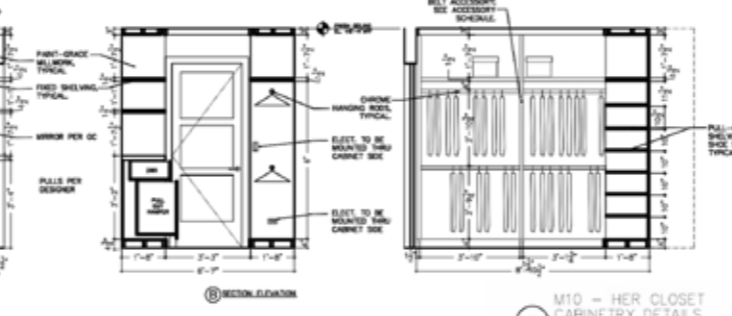

M10 - HER CLOSET CABINERY DETAILS SCALE: 1/2"=1'-0"

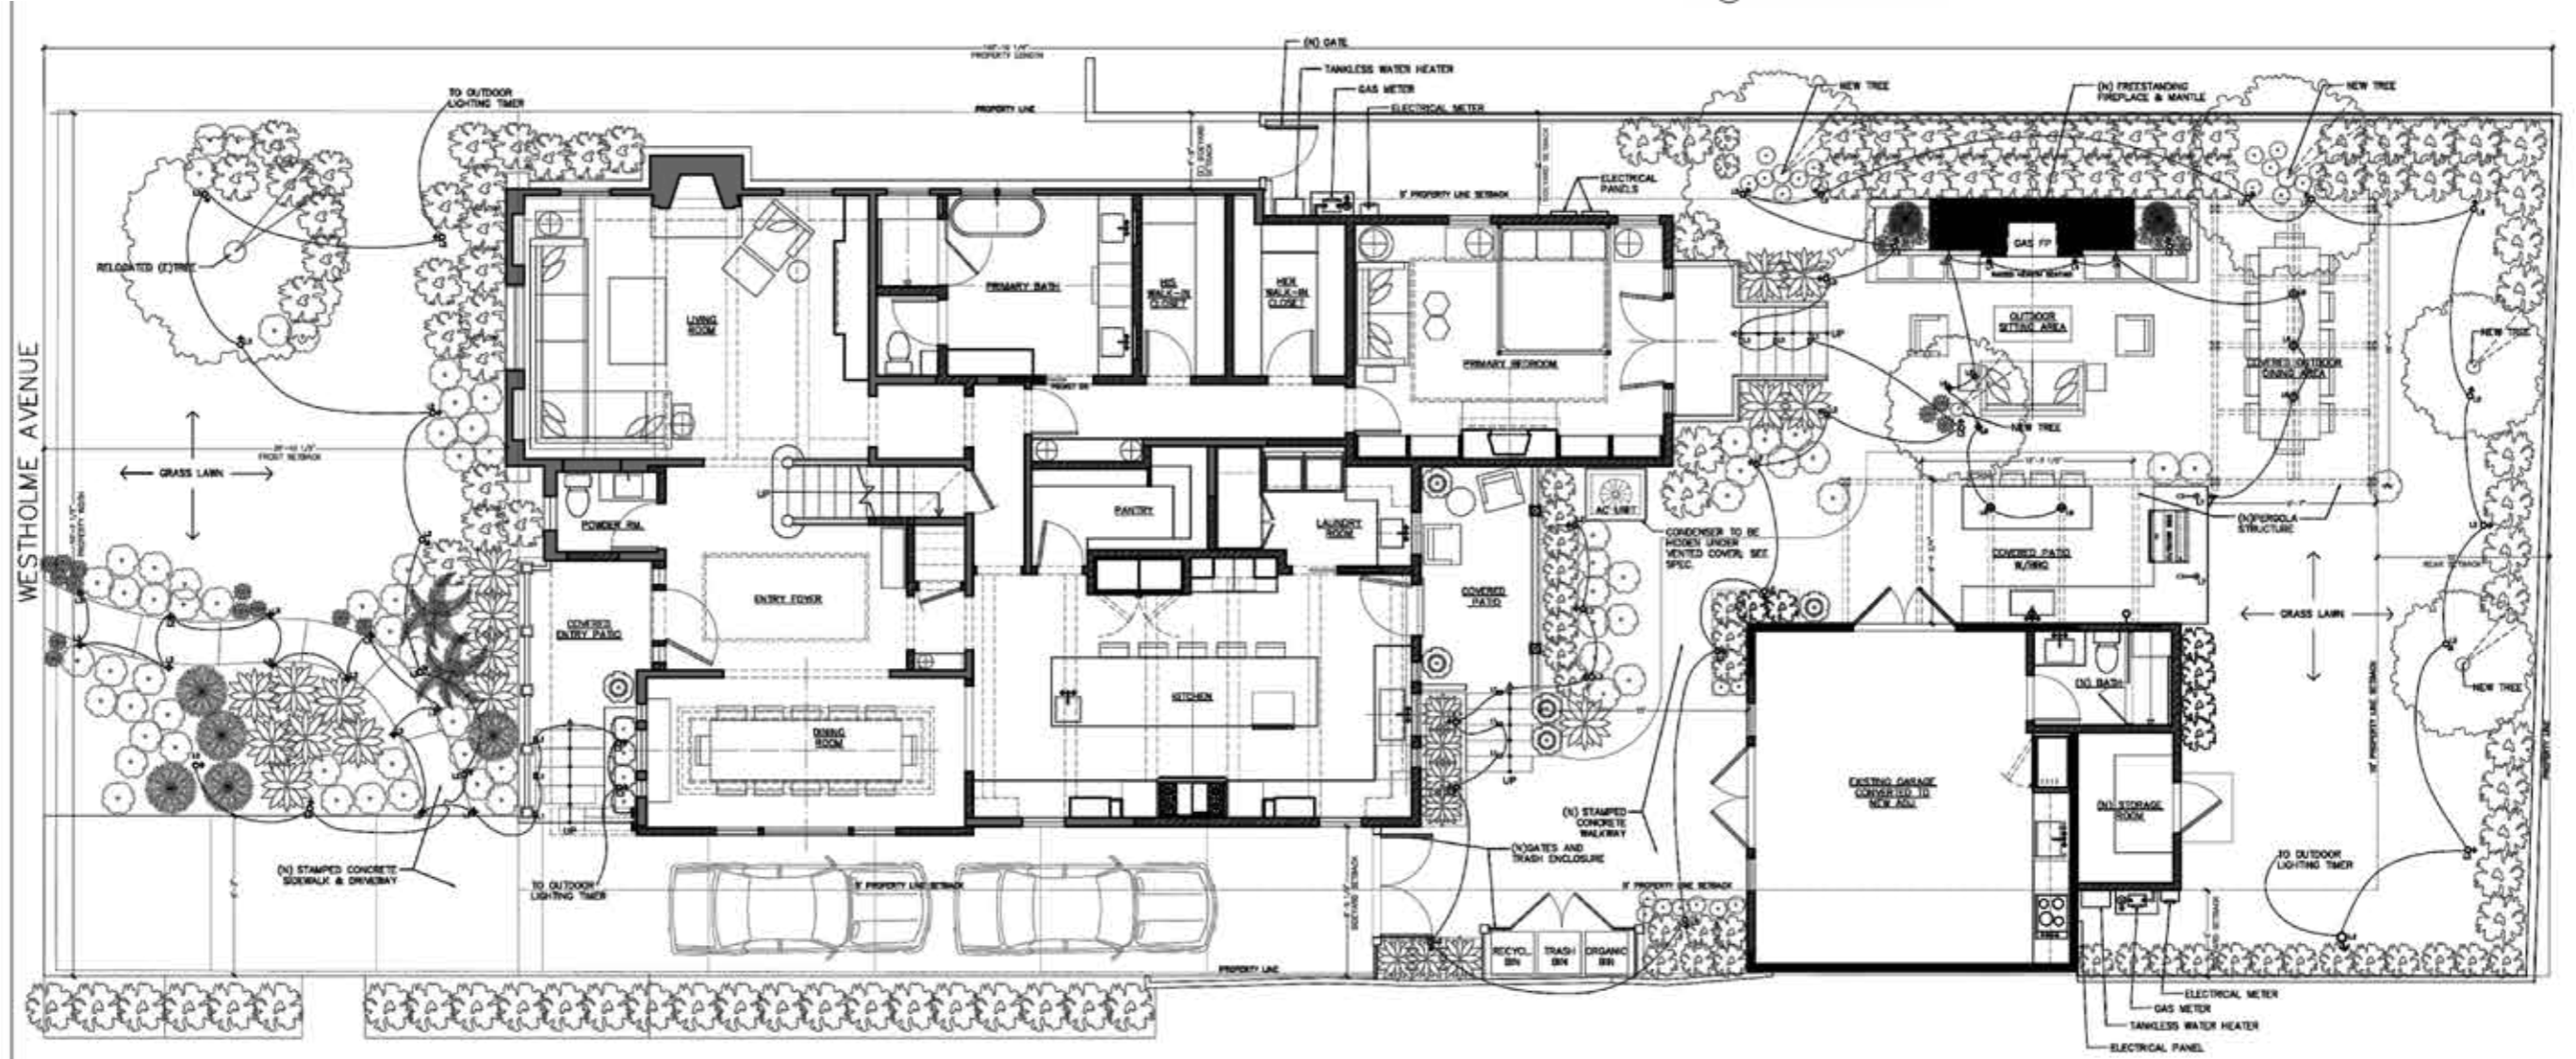

WESTHOLME AVENUE

(N) STAMPED CONCRETE SIDEWALK & DRIVEWAY

TO OUTDOOR LIGHTING TIMER

TO OUTDOOR LIGHTING TIMER

ELECTRICAL METER
TANKLESS WATER HEATER
ELECTRICAL PANEL


Olympiad

LA County - Residential - 2023


Schematic Design > Design Development

> Construction Documents





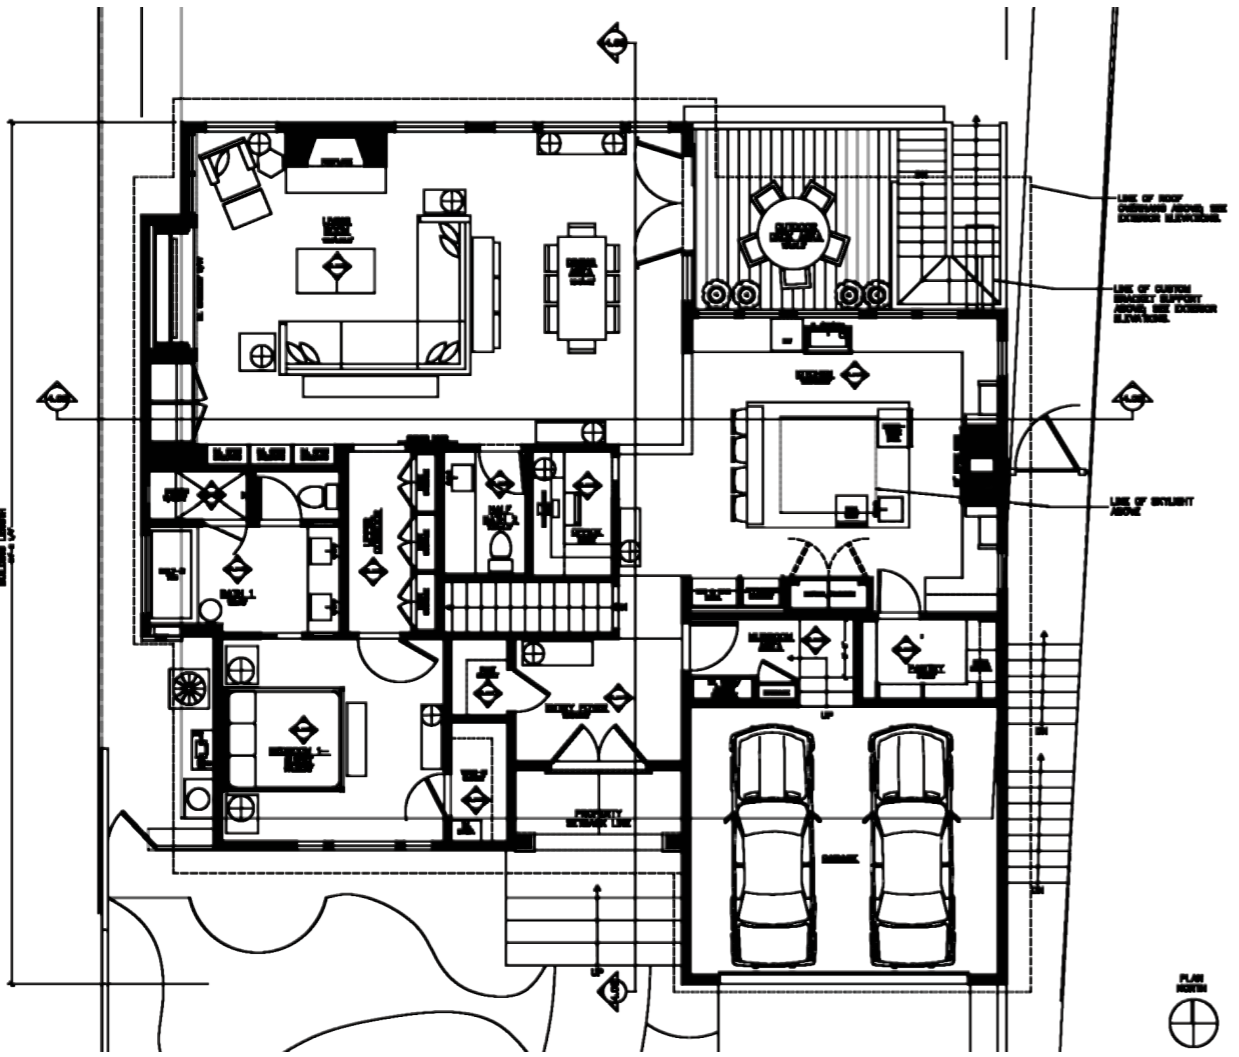


2 REAR EXTERIOR ELEVATION
SCALE: 1/8"=1'-0"

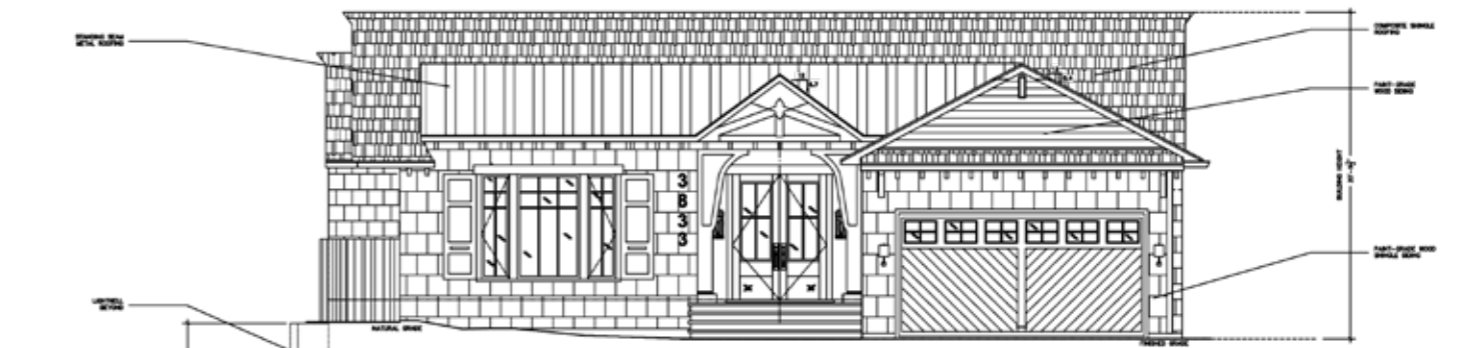

1 FRONT EXTERIOR ELEVATION
SCALE: 1/8"=1'-0"

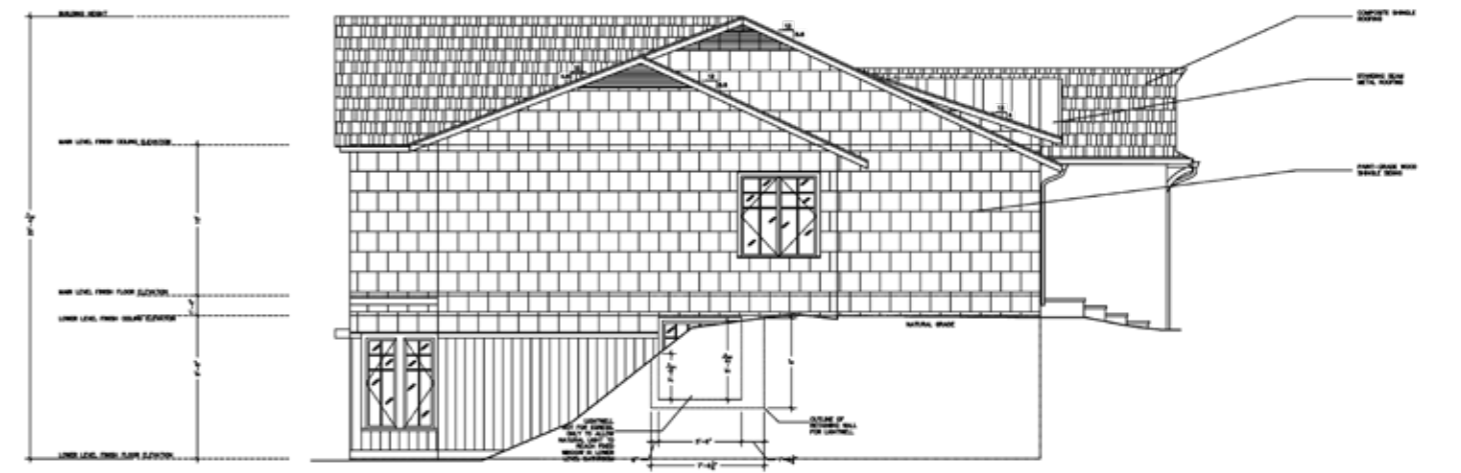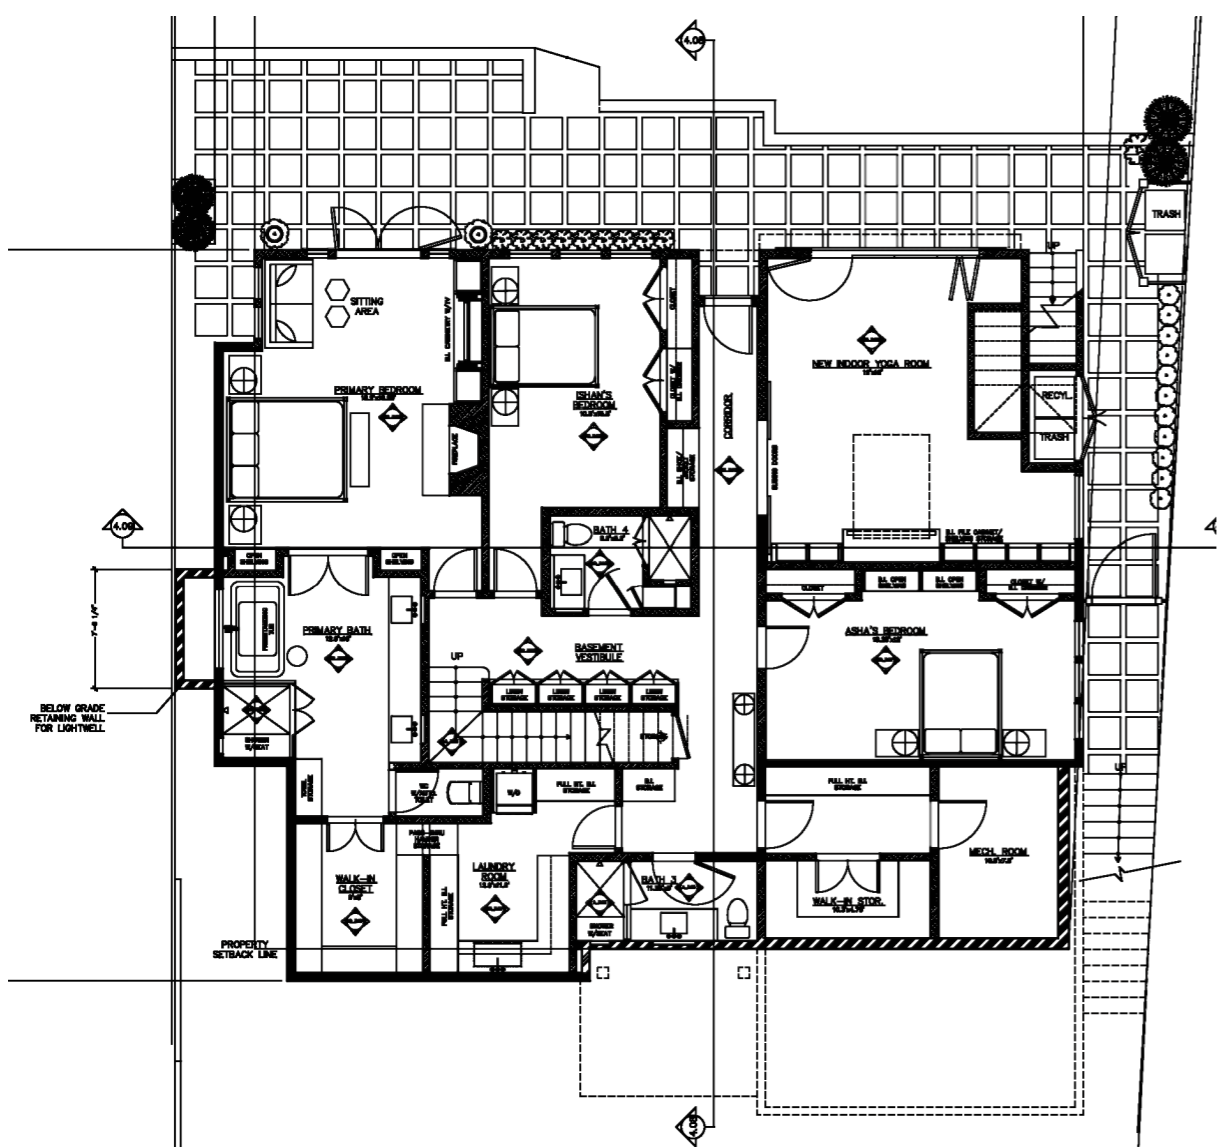

2 REAR EXTERIOR ELEVATION
SCALE: 1/8"=1'-0"

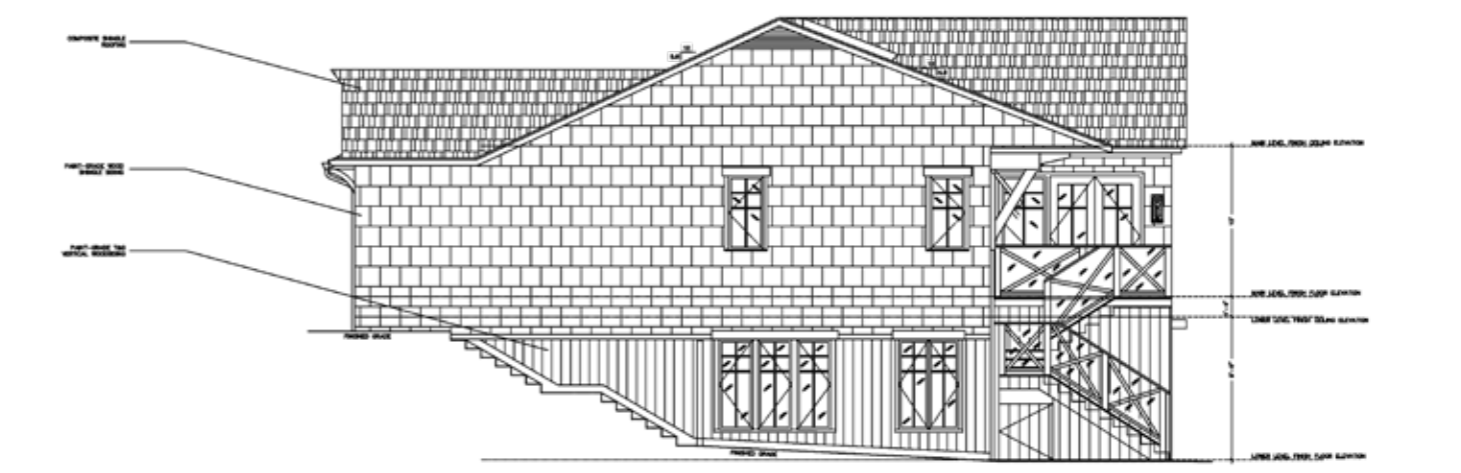

1 EAST EXTERIOR ELEVATION
SCALE: 1/8"=1'-0"

Canyon

Hollywood Grove HPOZ - Residential - 2023


Schematic Design > Design Development >

Construction Documents > Construction



Awarding > Construction

Administration



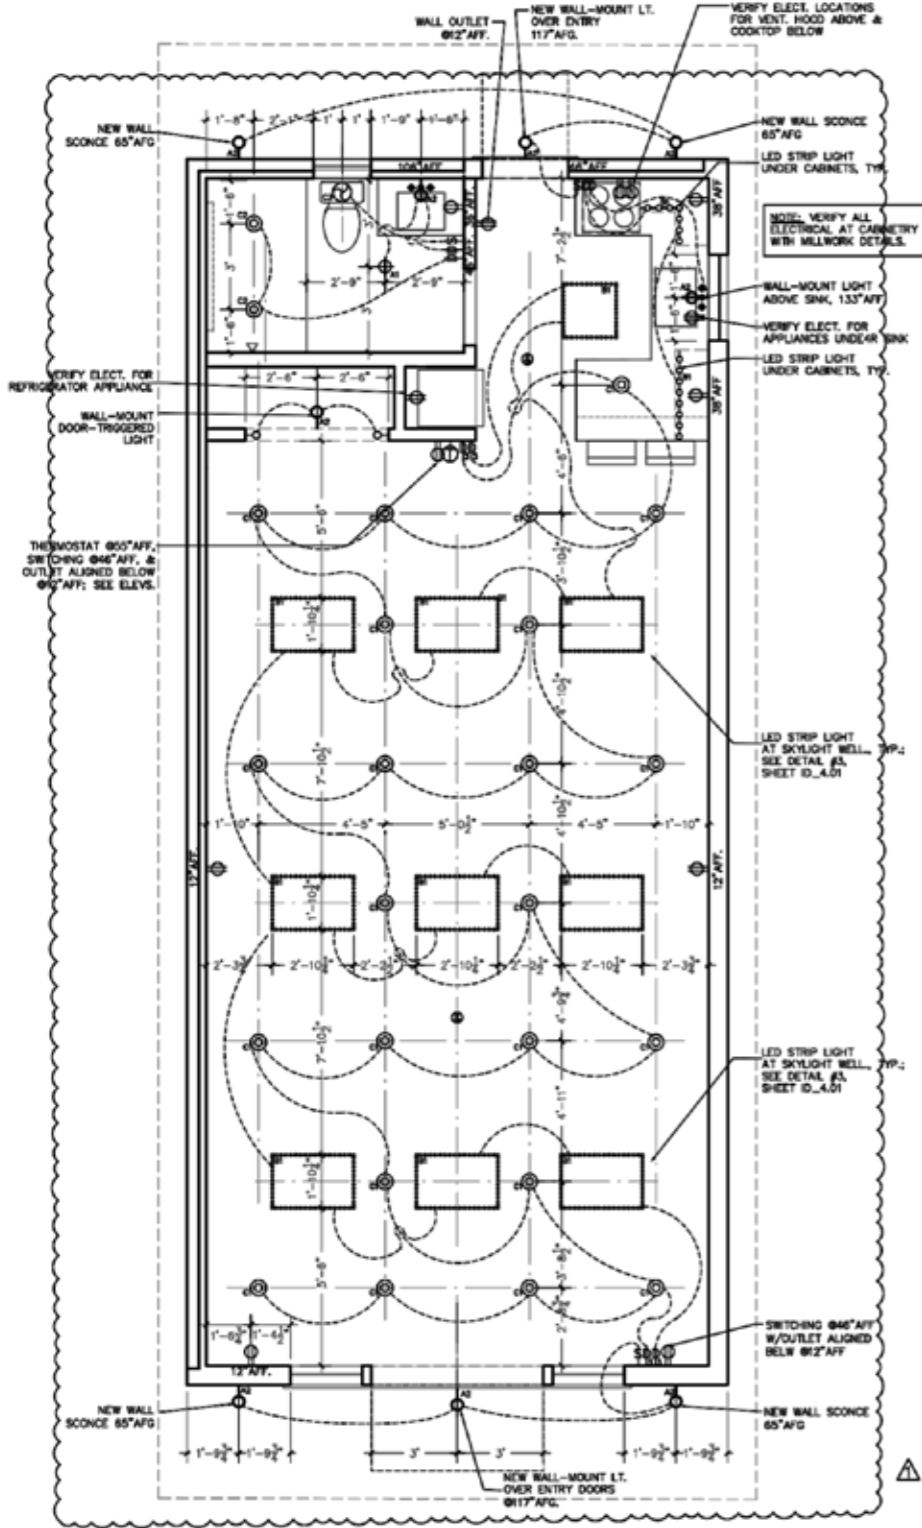

2 LIGHTING AND ELECTRICAL PLAN
SCALE: 3/8"=1'-0"

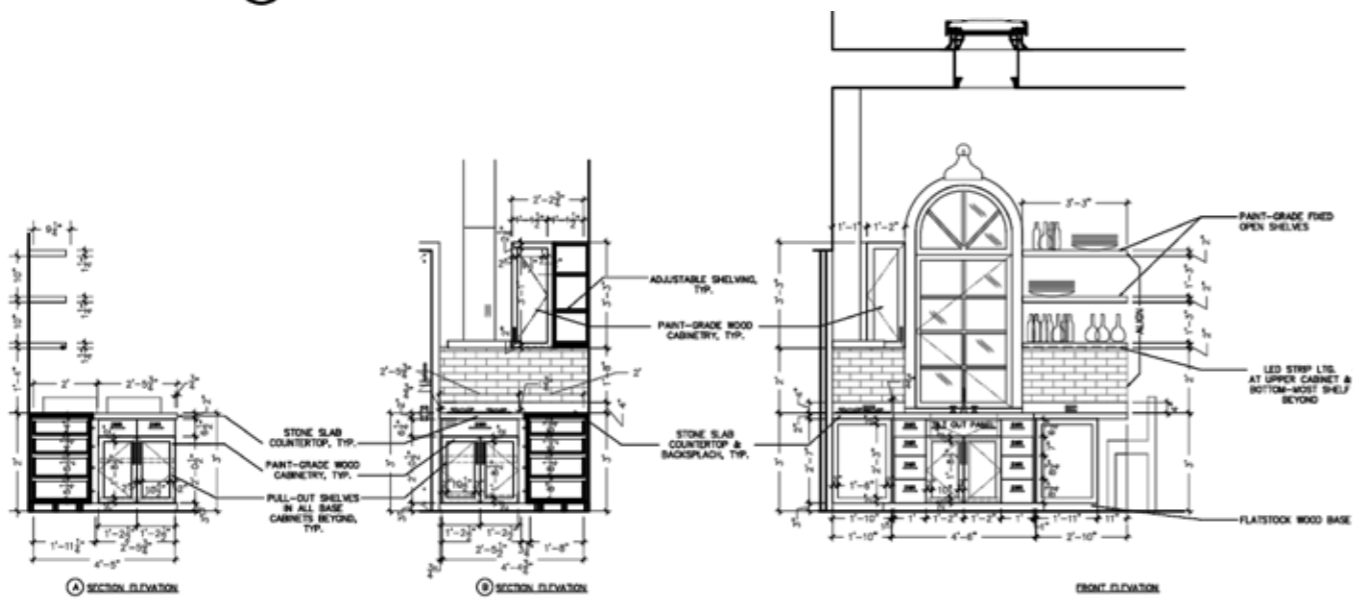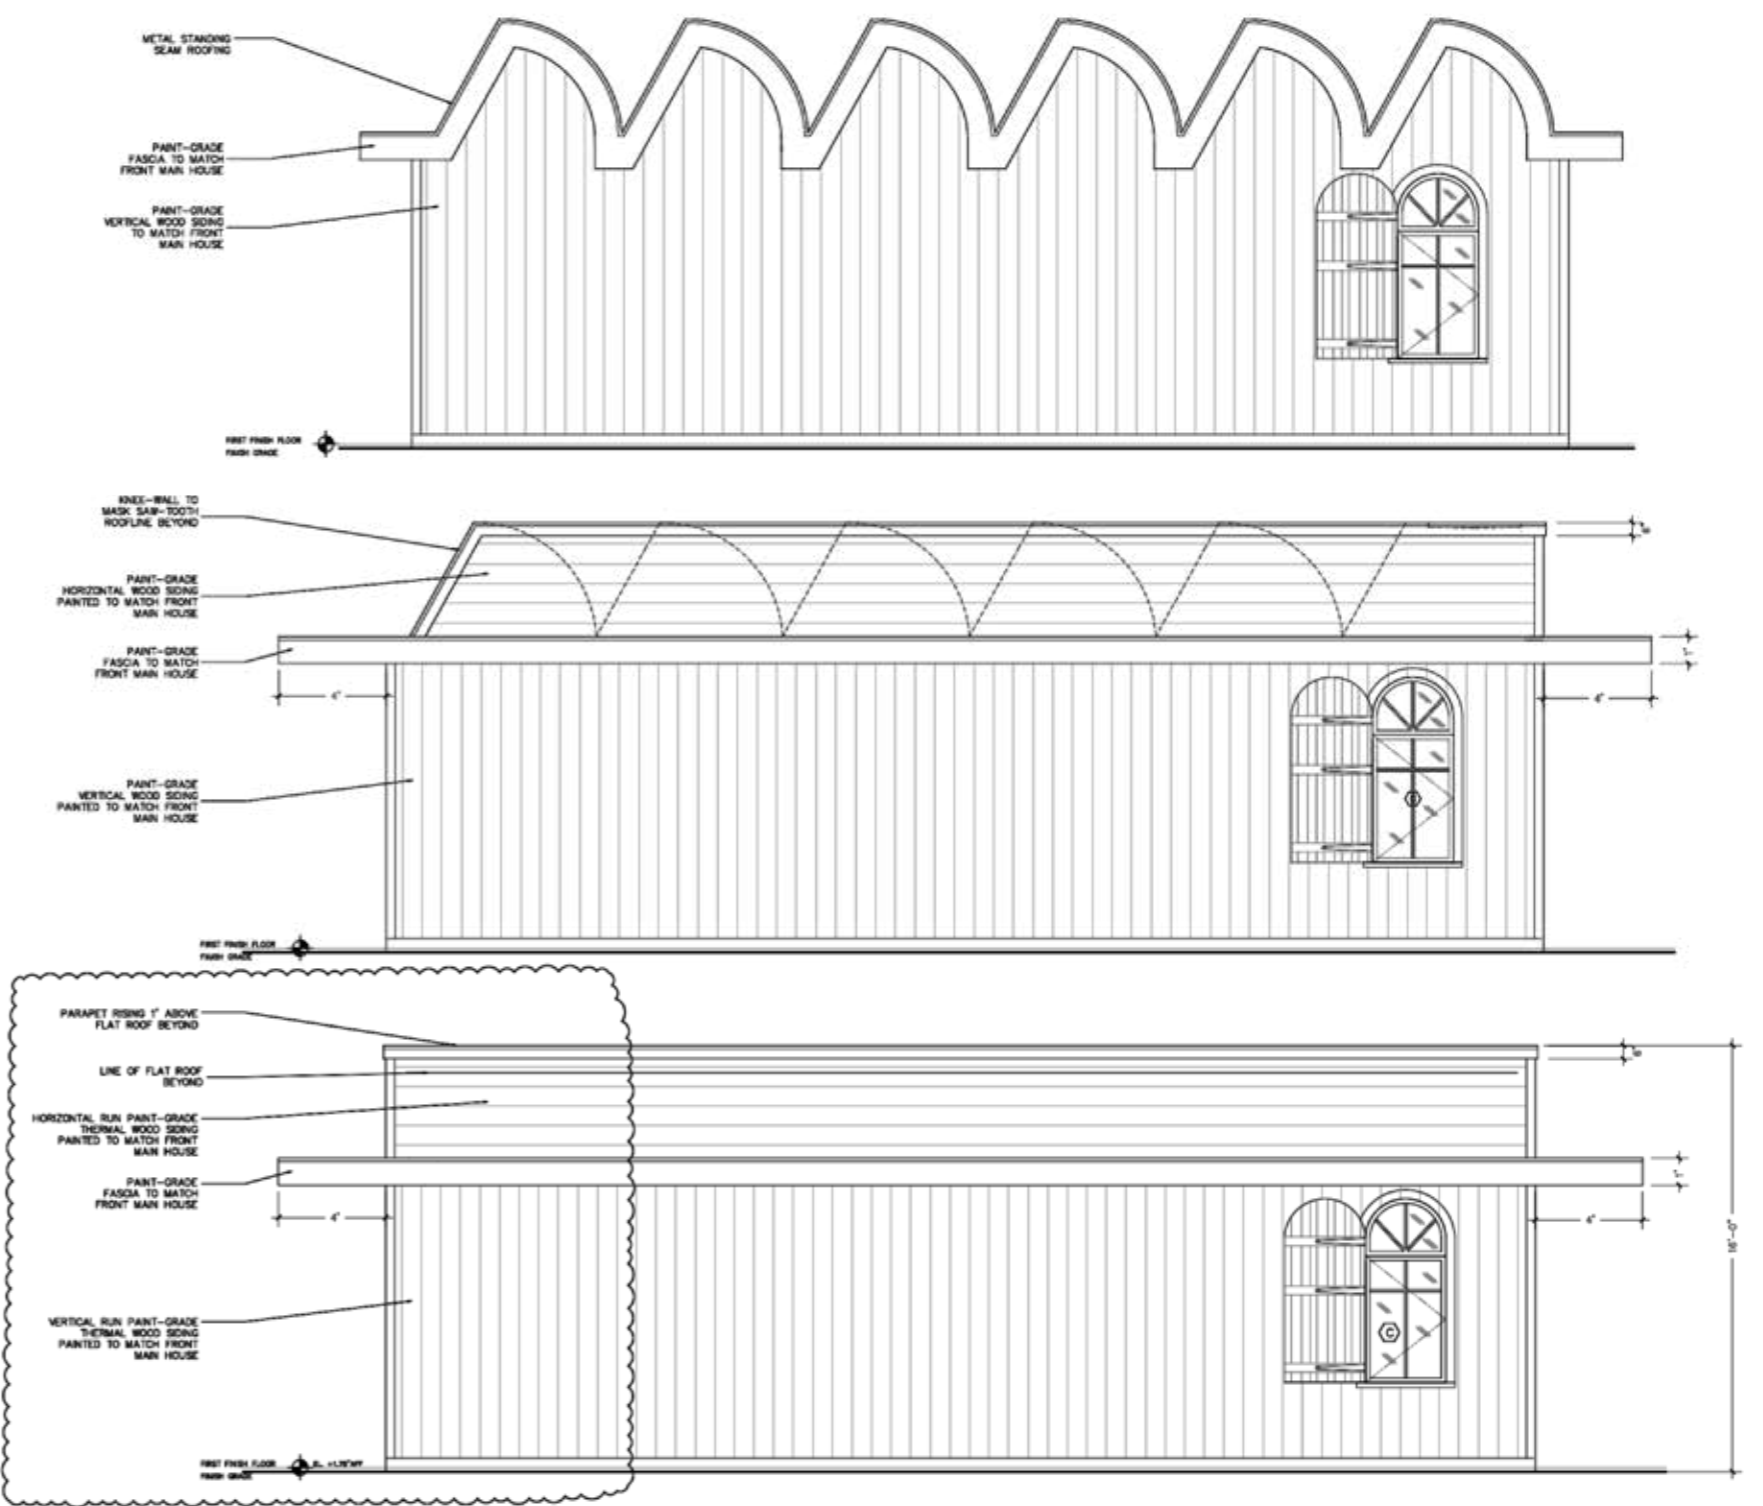

Admiral

West Los Angeles - Residential - 2021






Schematic Design > Design Development >

Construction Documents > Construction

Awarding > Construction

Administration



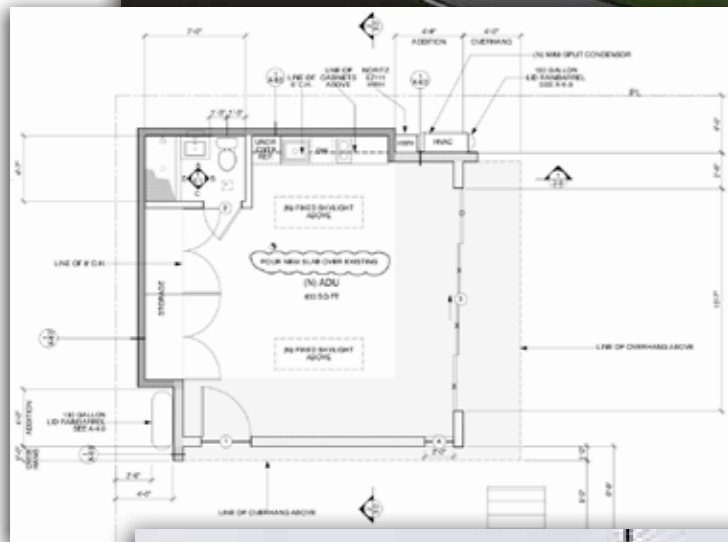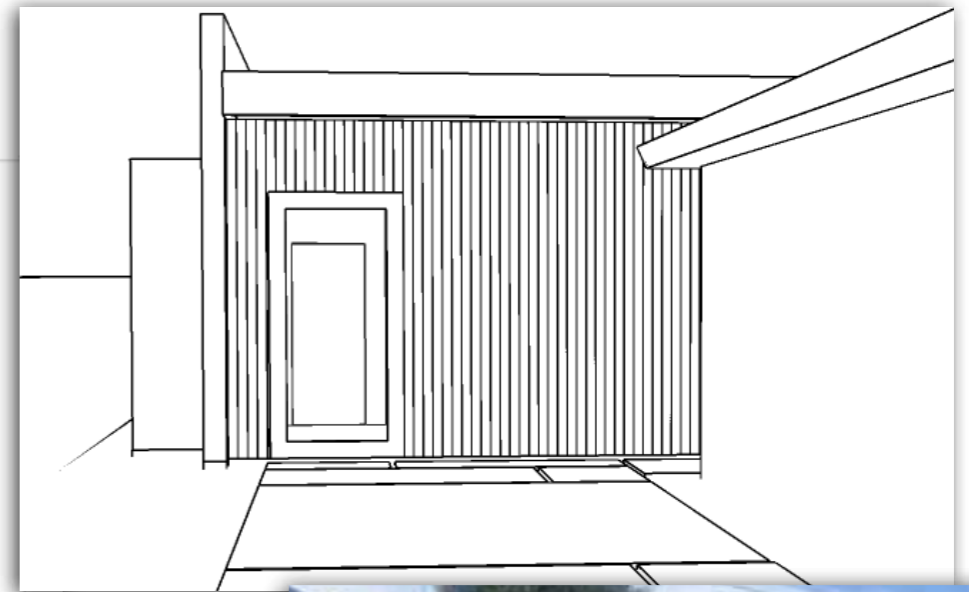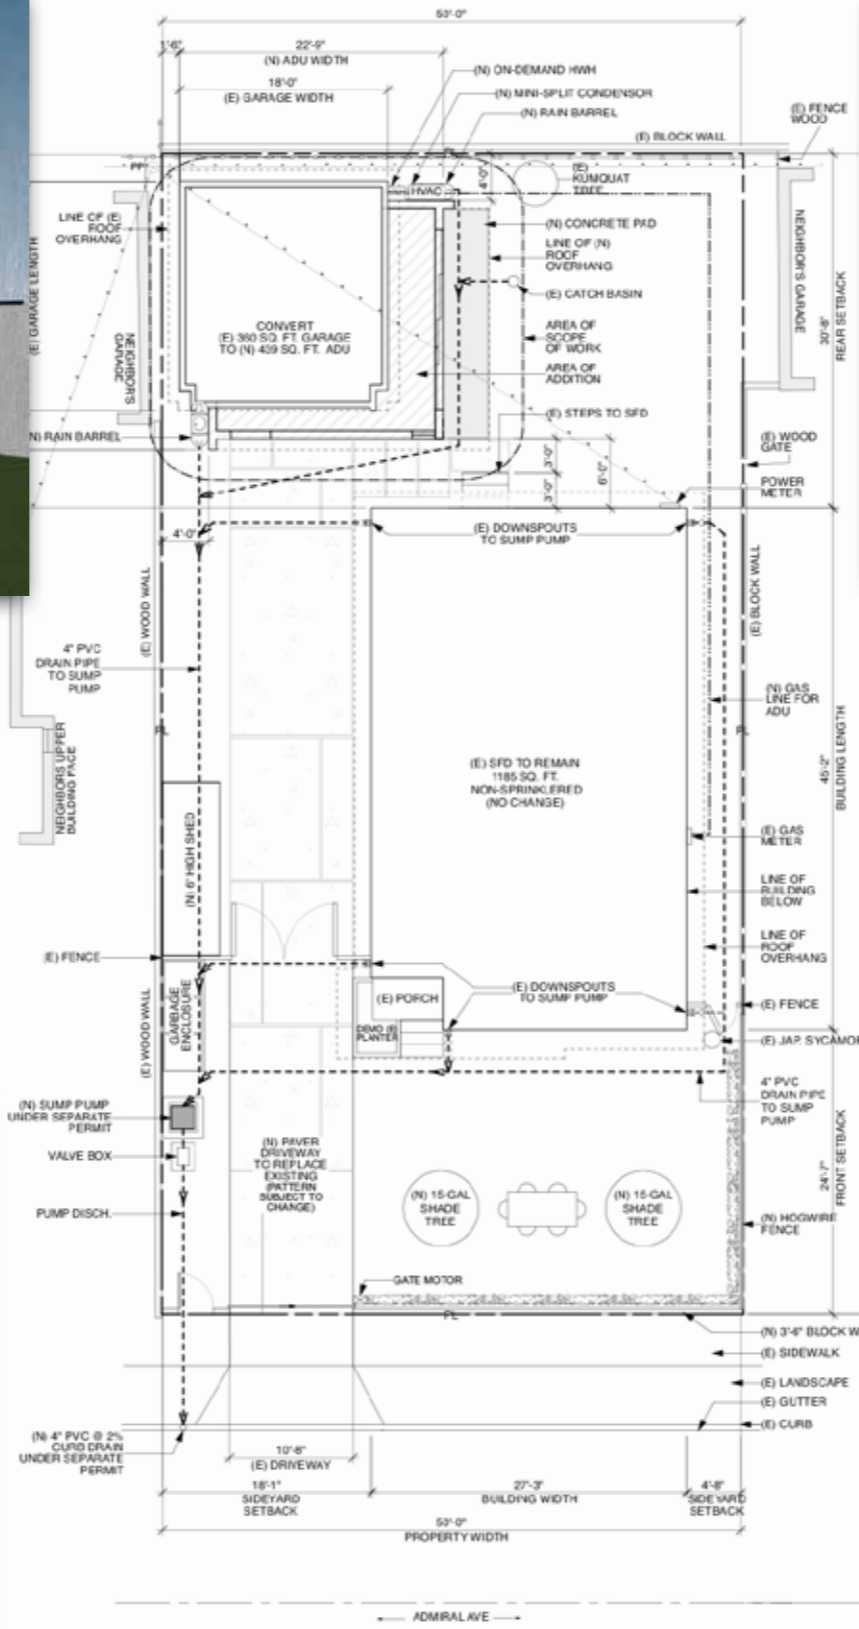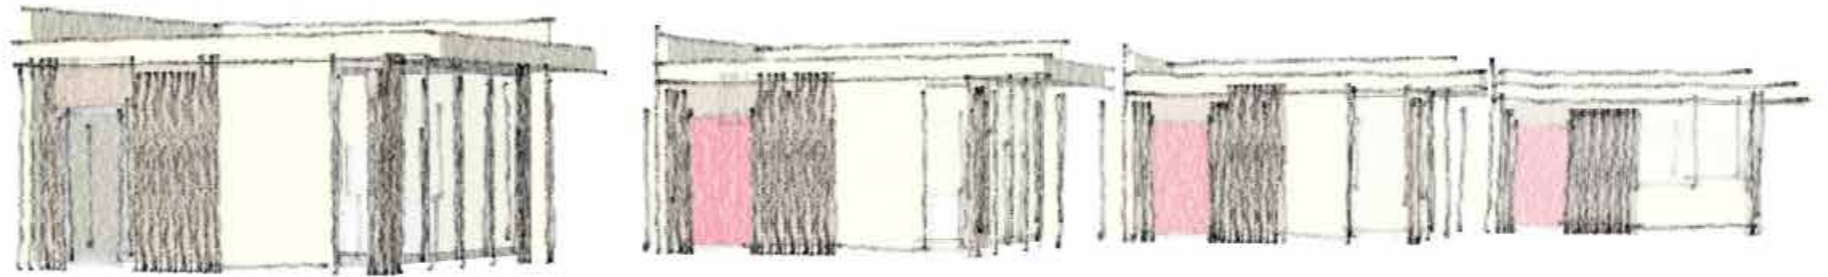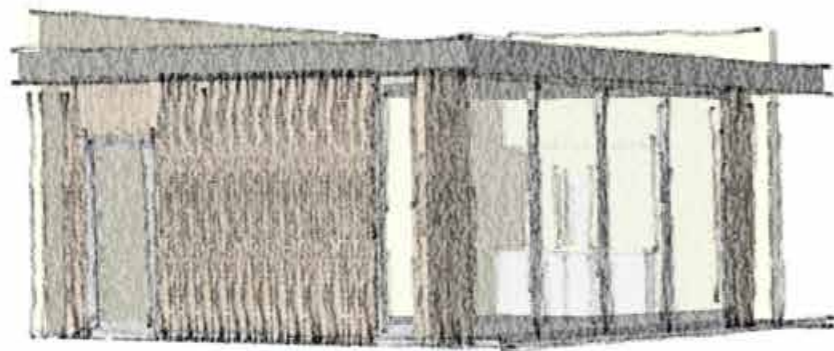

Clune




Venice - Residential - 2021

[Schematic Design >](#)

[Design Development >](#)

[Construction Documents](#)



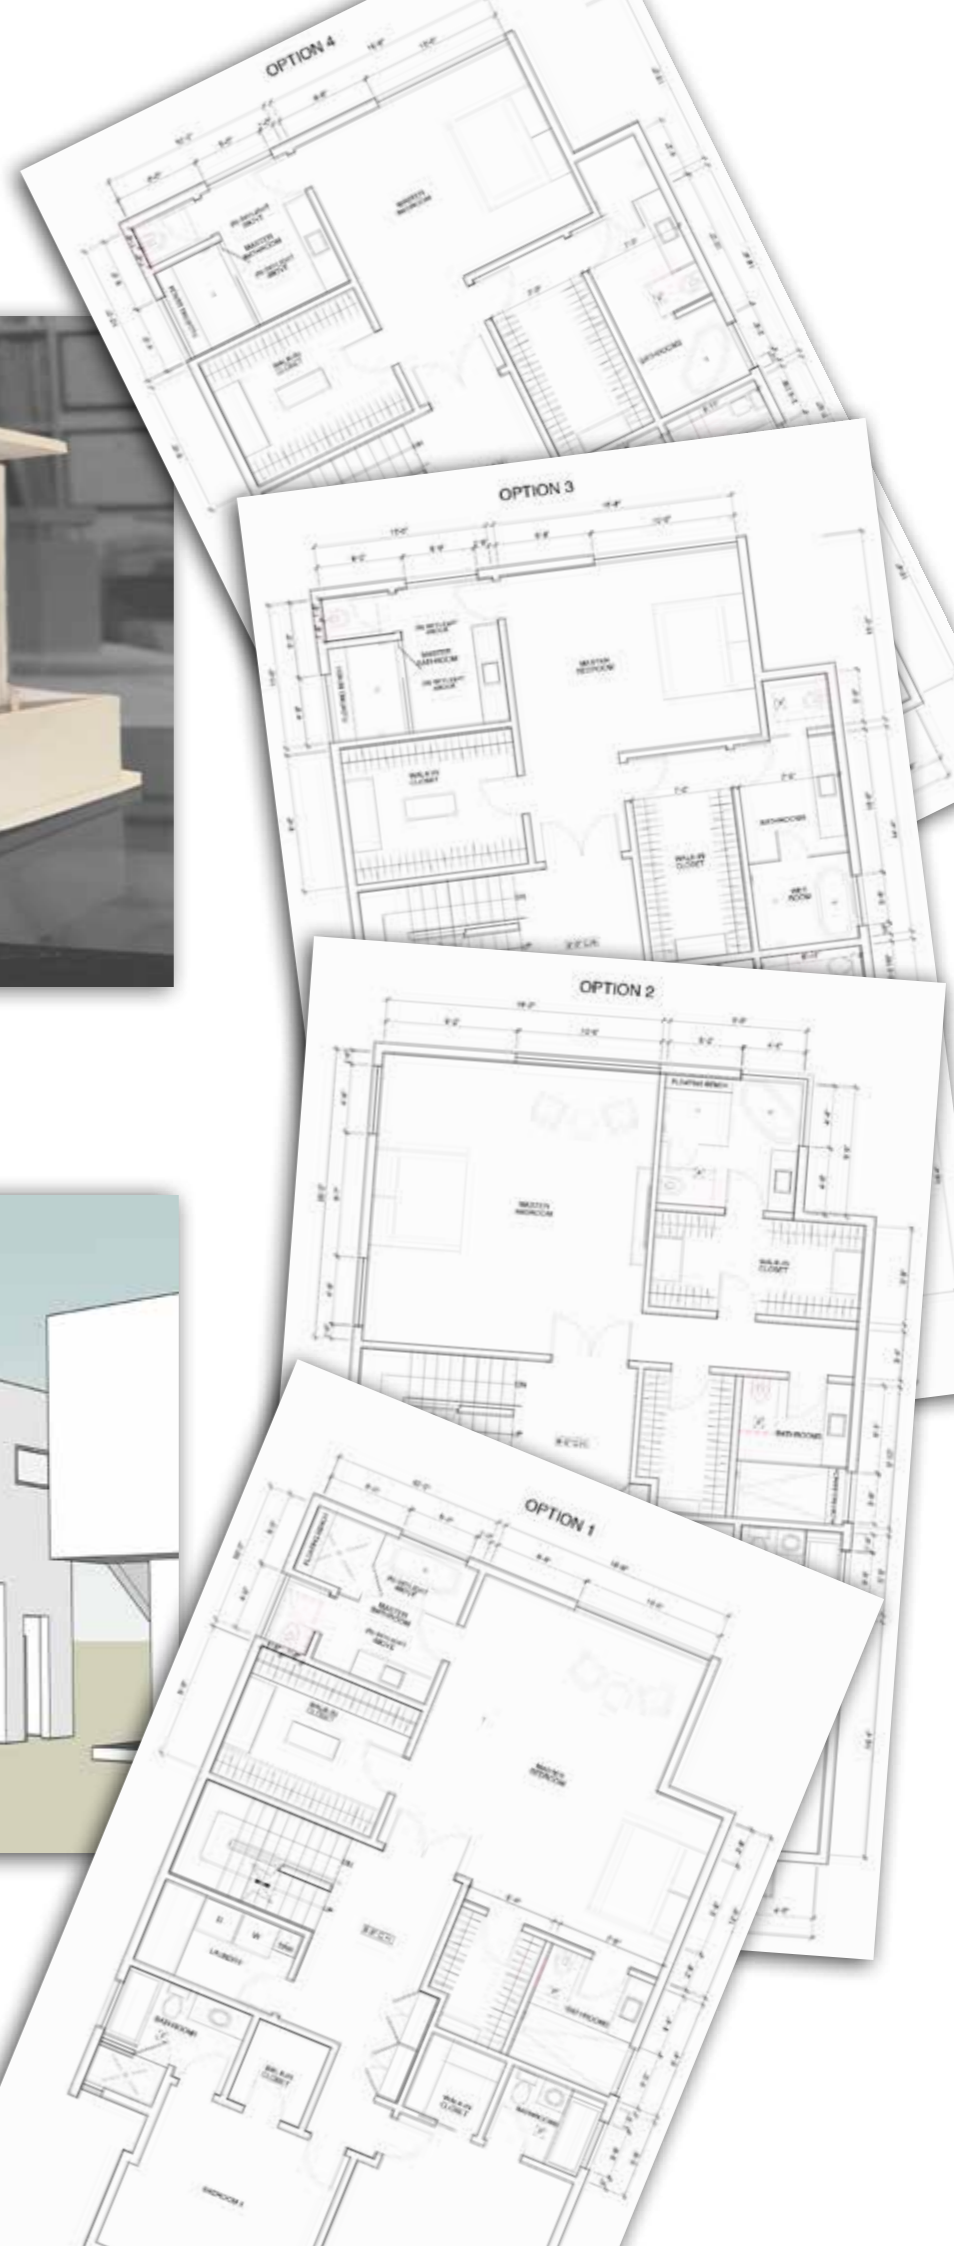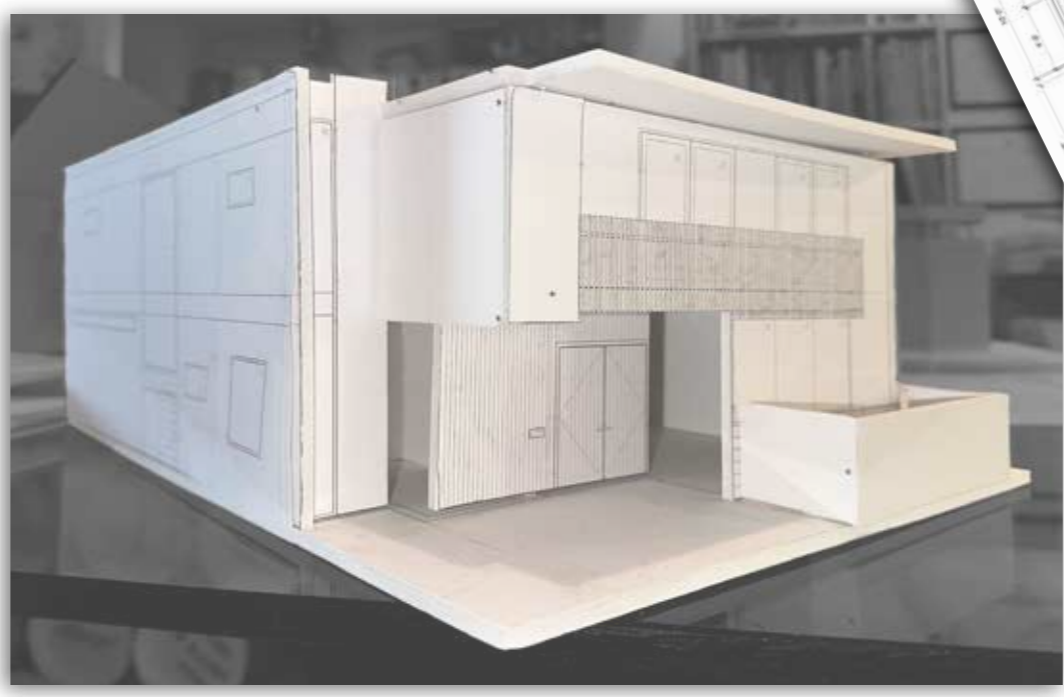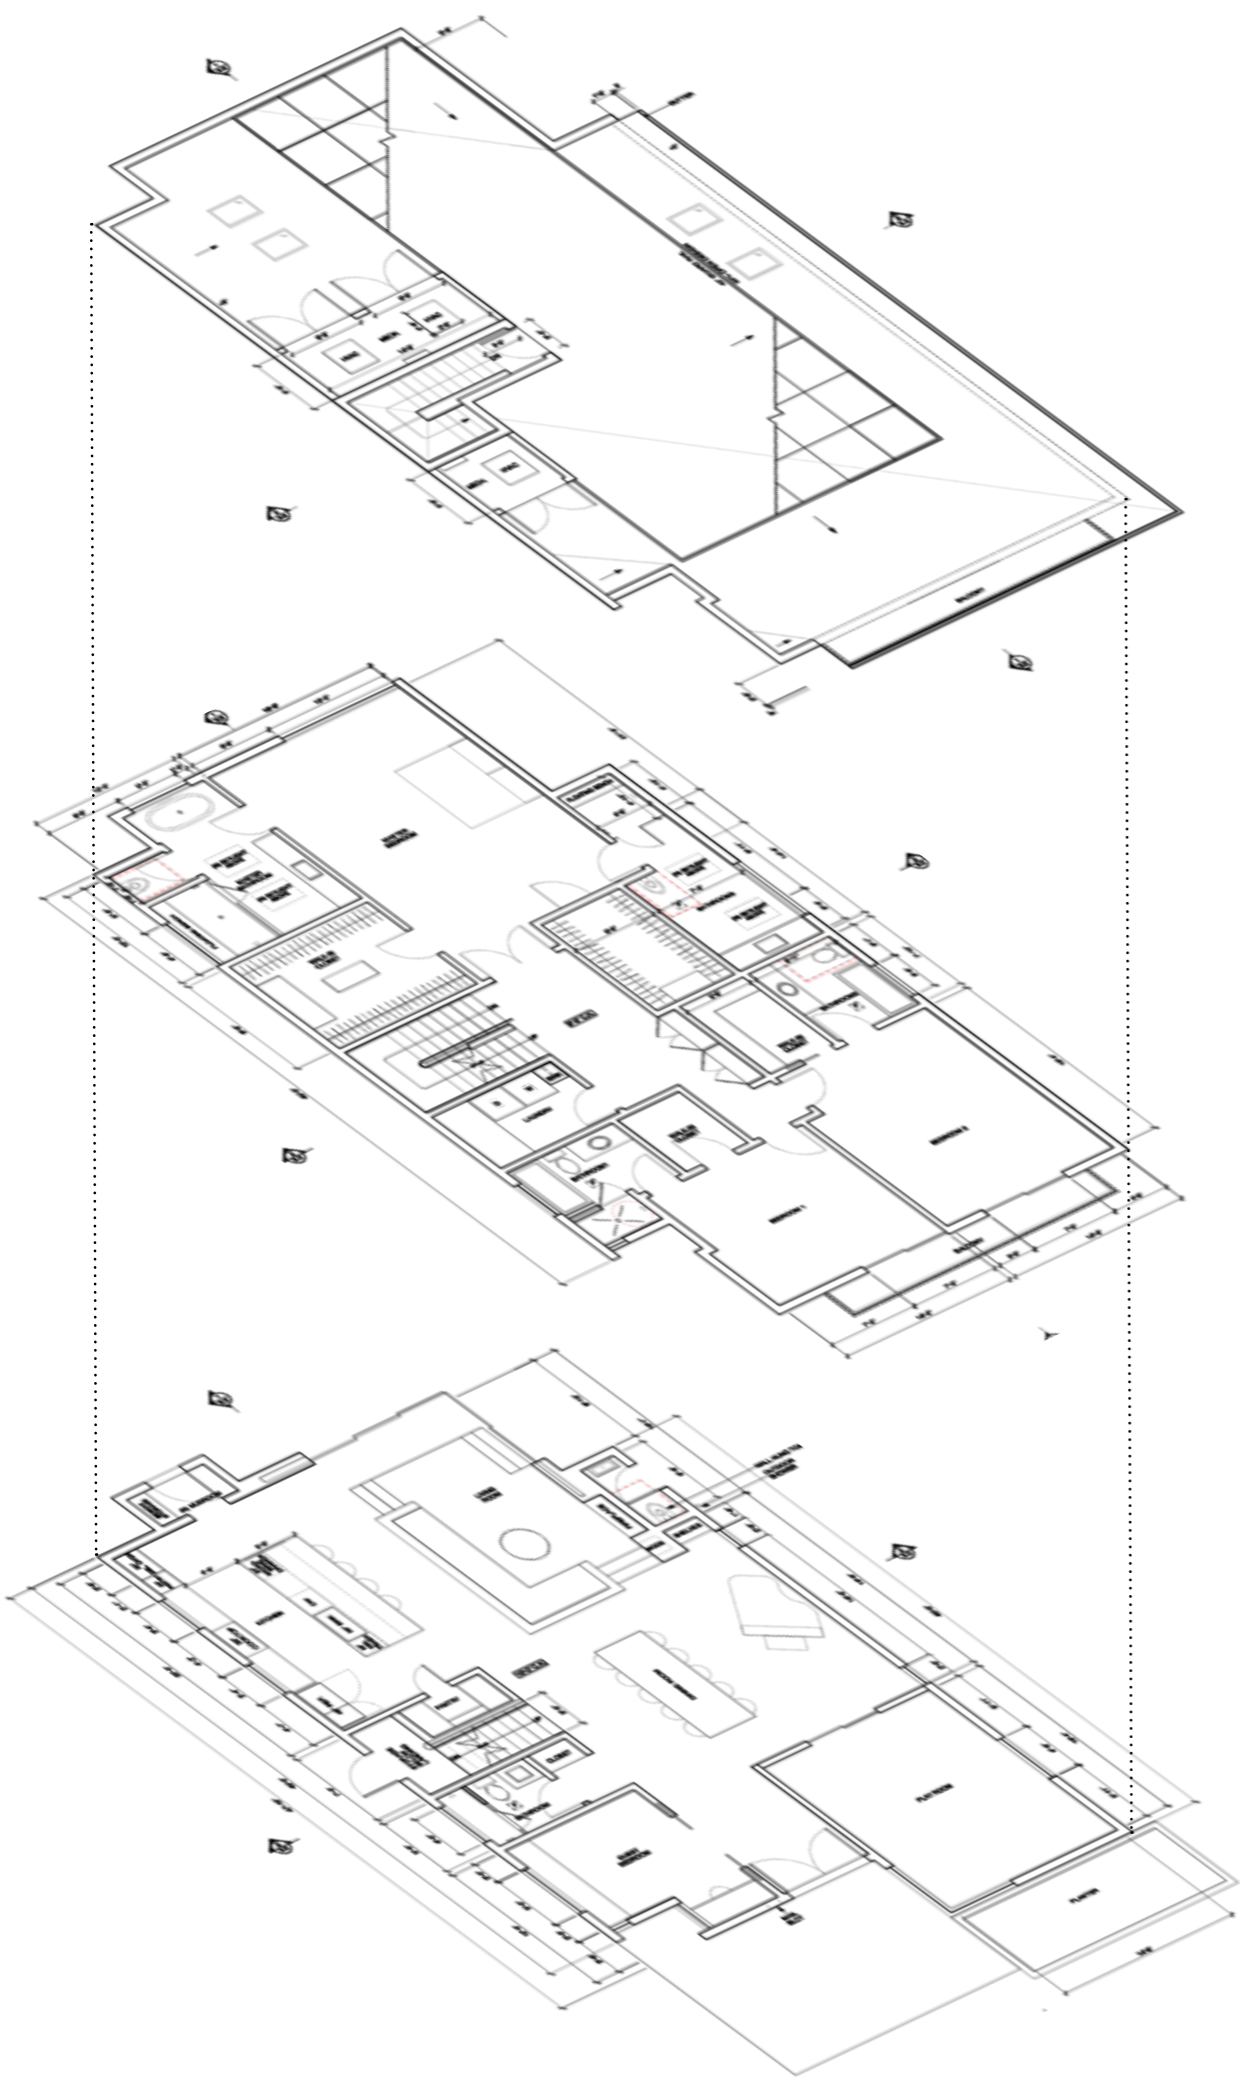

Windsor

Windsor Park HPOZ

Residential - 2022

Schematic - Development -

Rendering - Permitting






Market

Venice - Commercial - 2020

3D modeling - Rendering



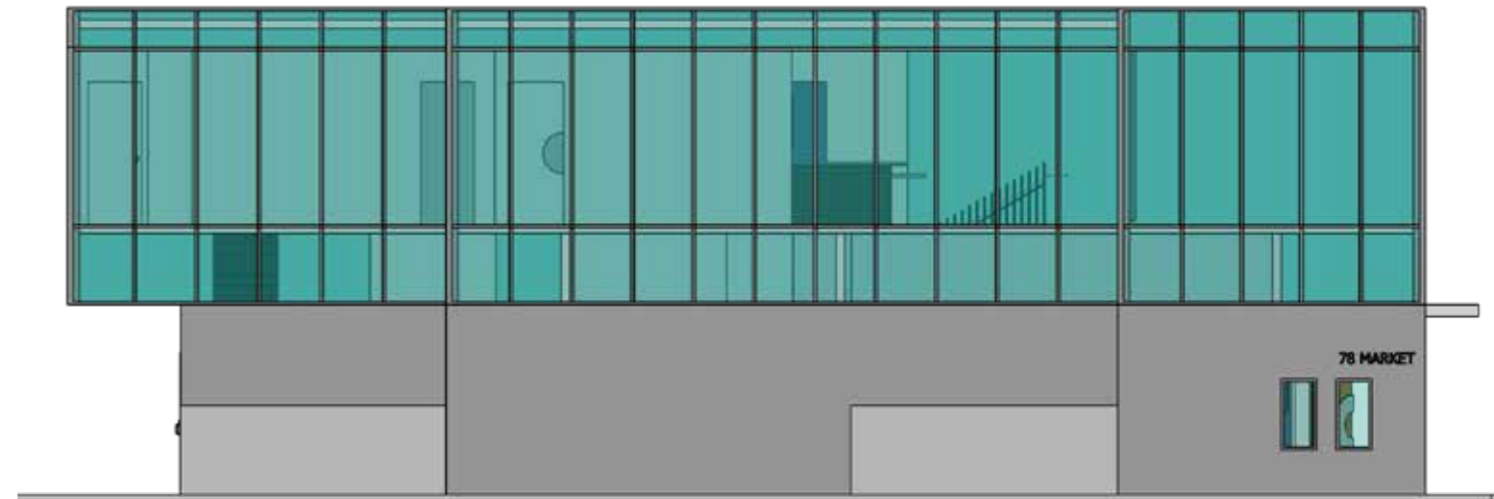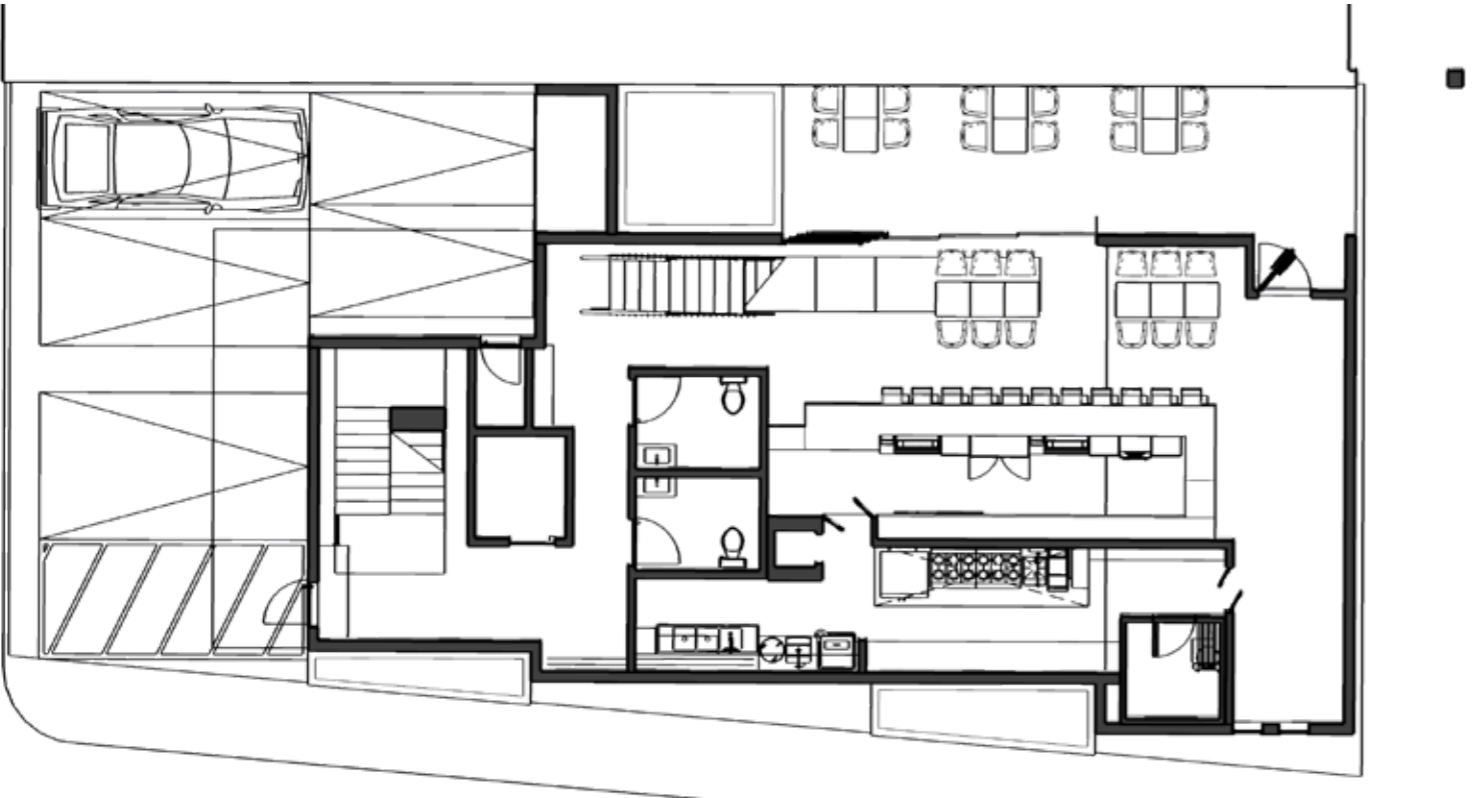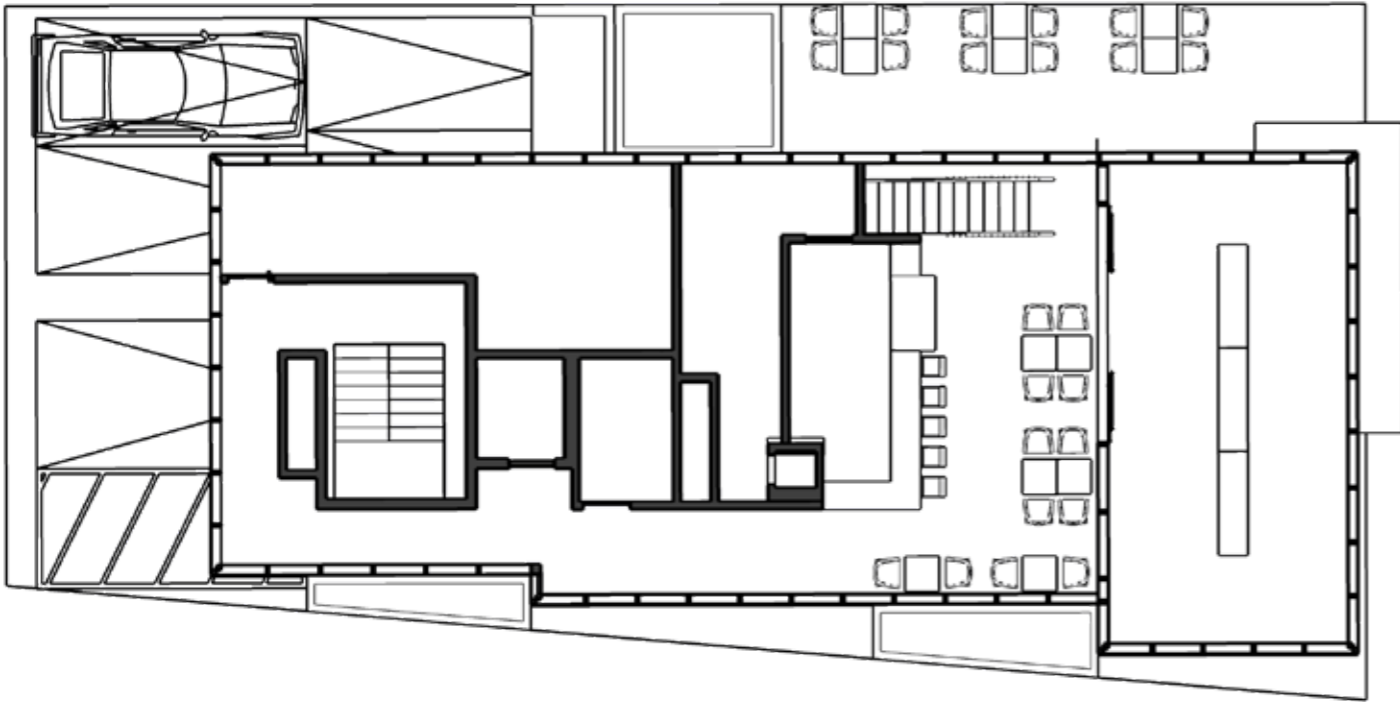

Bird/house

UCLA Extension - 2021

Fundamentals of Interior Architecture I

Winner of James Northcutt Scholarship

Inspired by Santiago Calatrava

